




FIRST FLOOR PLUMBING PLAN
1/8"=1'-0"

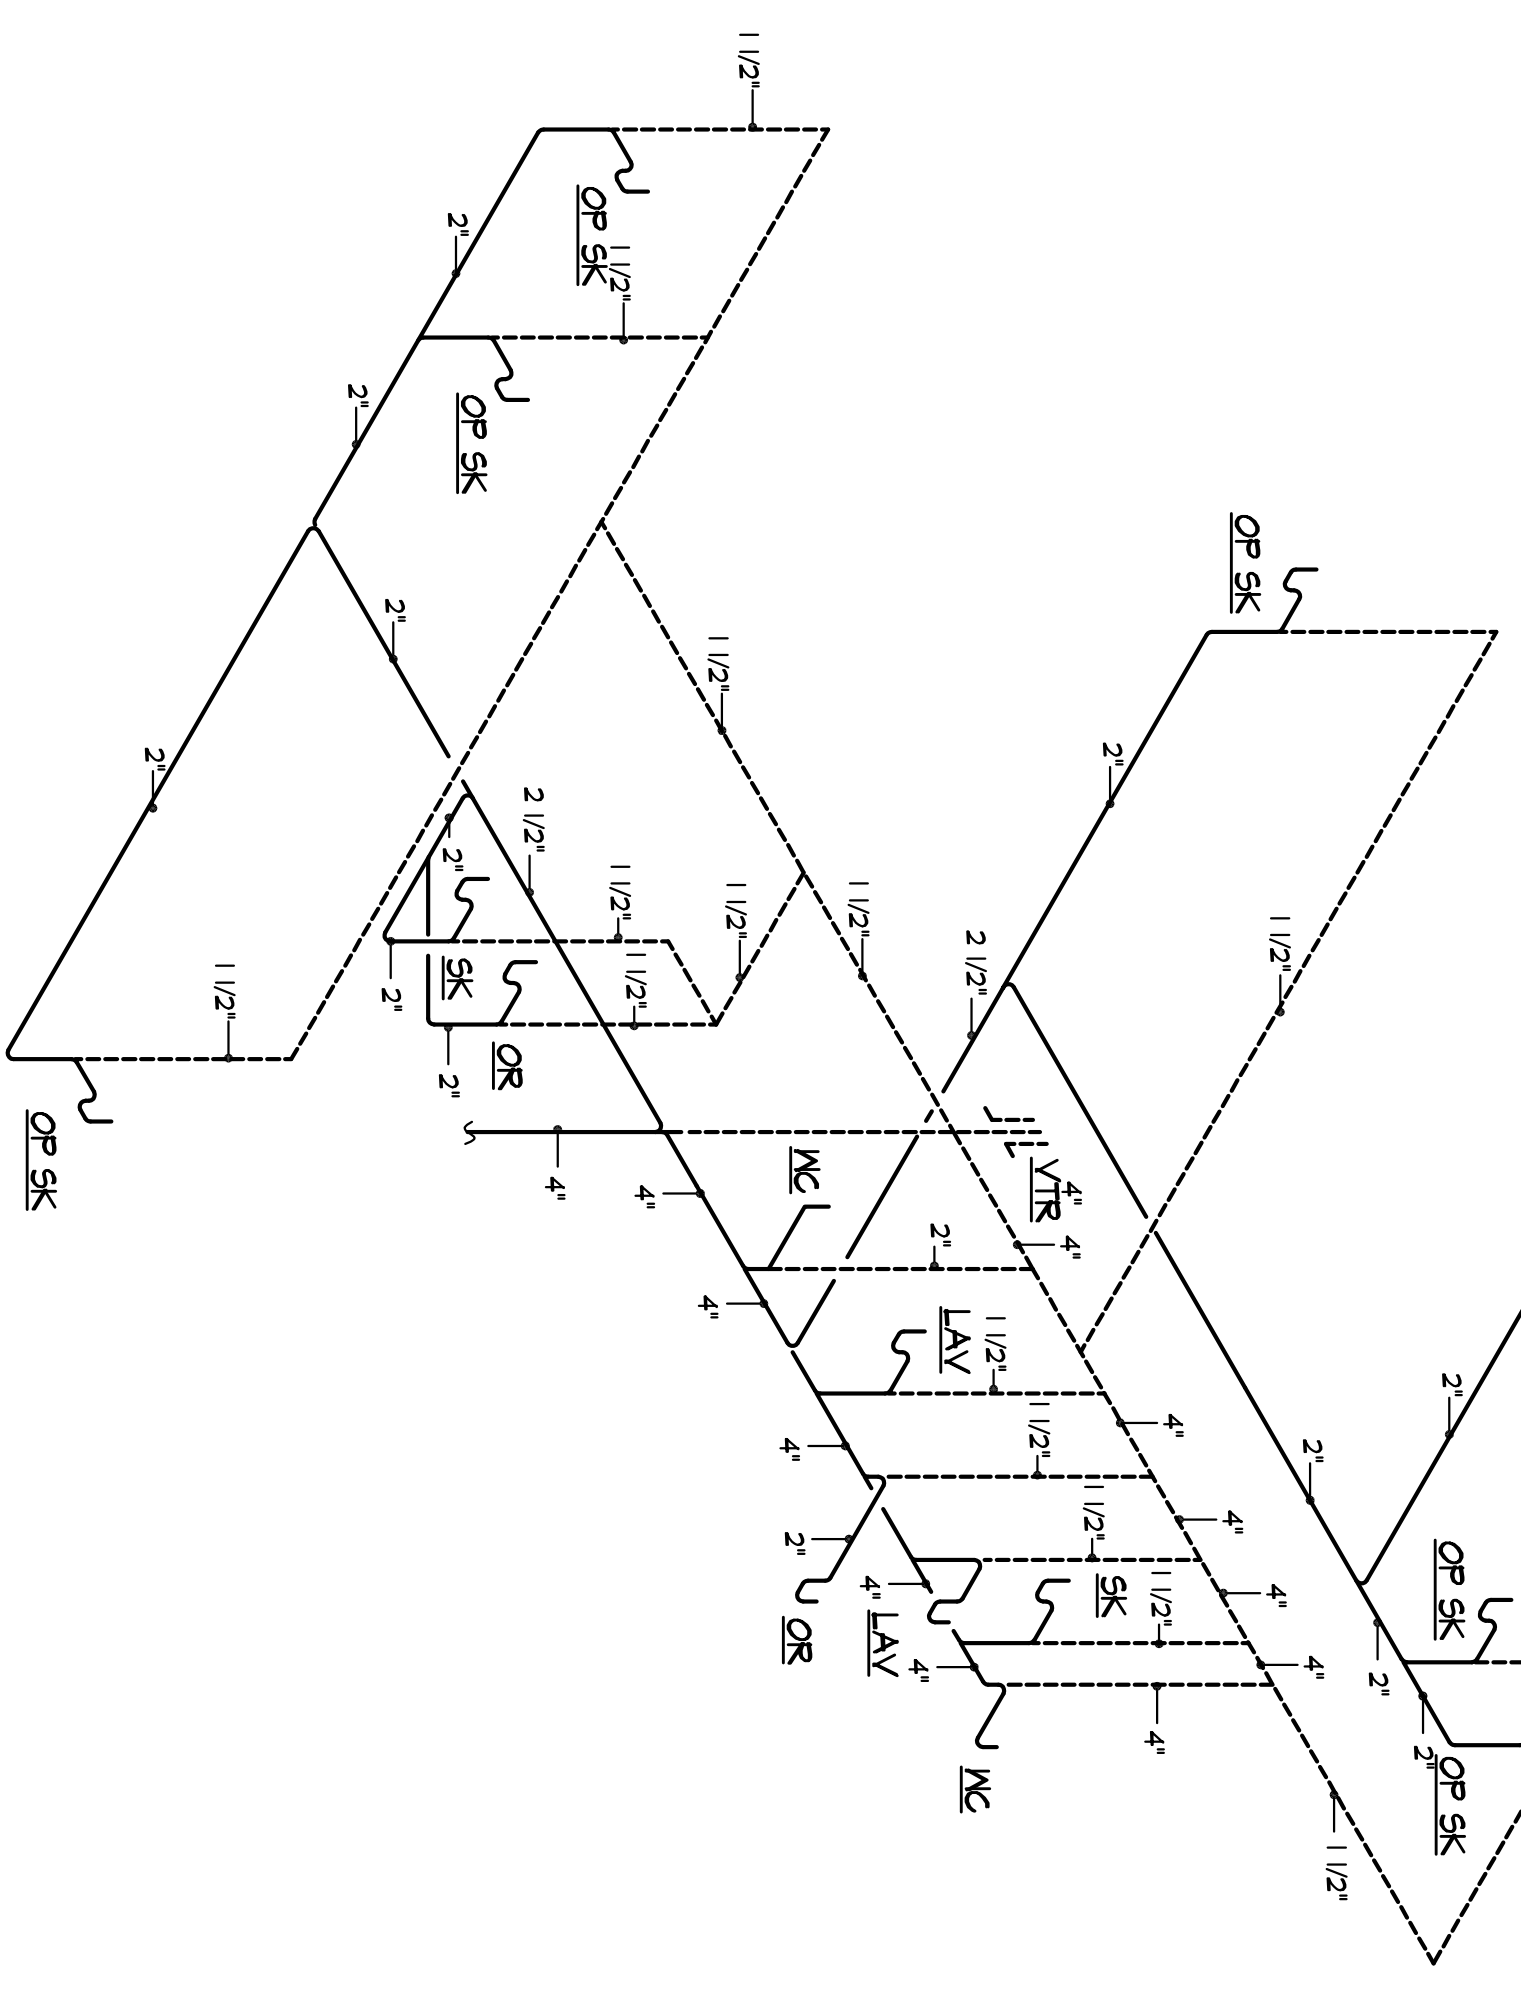

SOIL, WASTE & VENT RISER DIAGRAM
DR. R. JACKSON FIT-UP (SECOND FLOOR)
NO SCALE

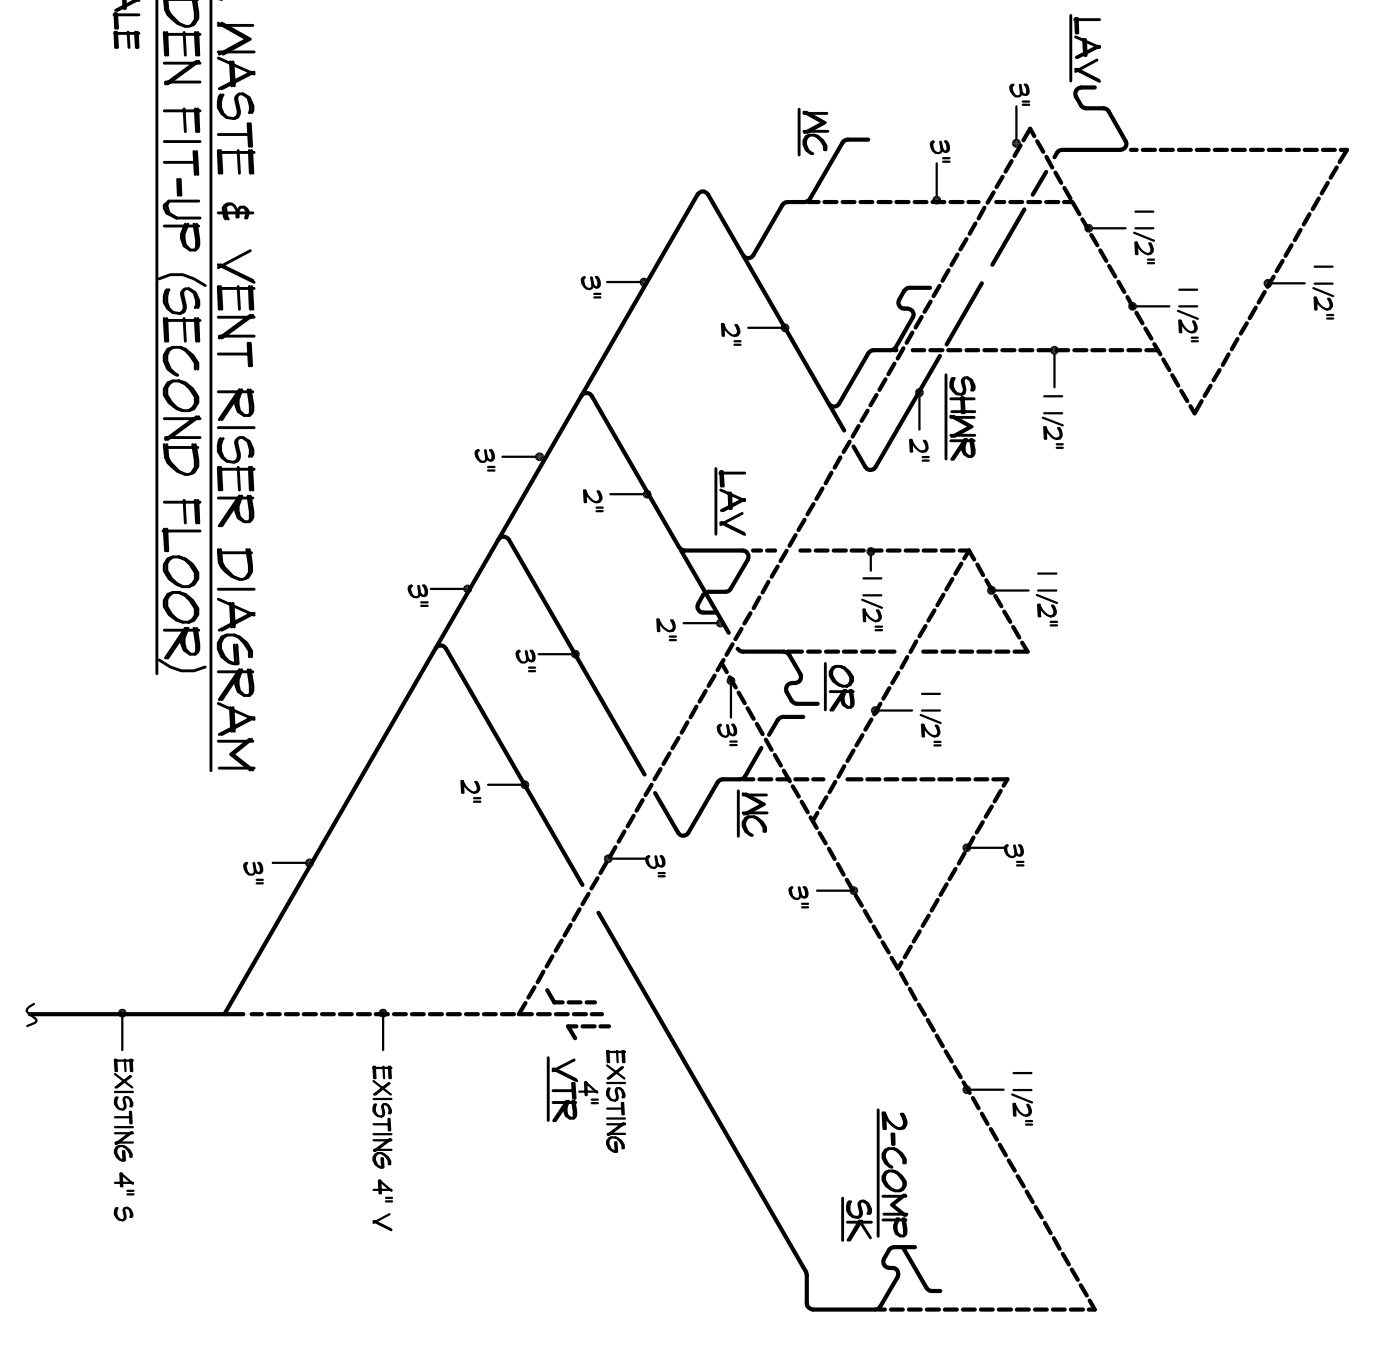

SOIL, WASTE & VENT RISER DIAGRAM
MADDEN FIT-UP (SECOND FLOOR)
NO SCALE

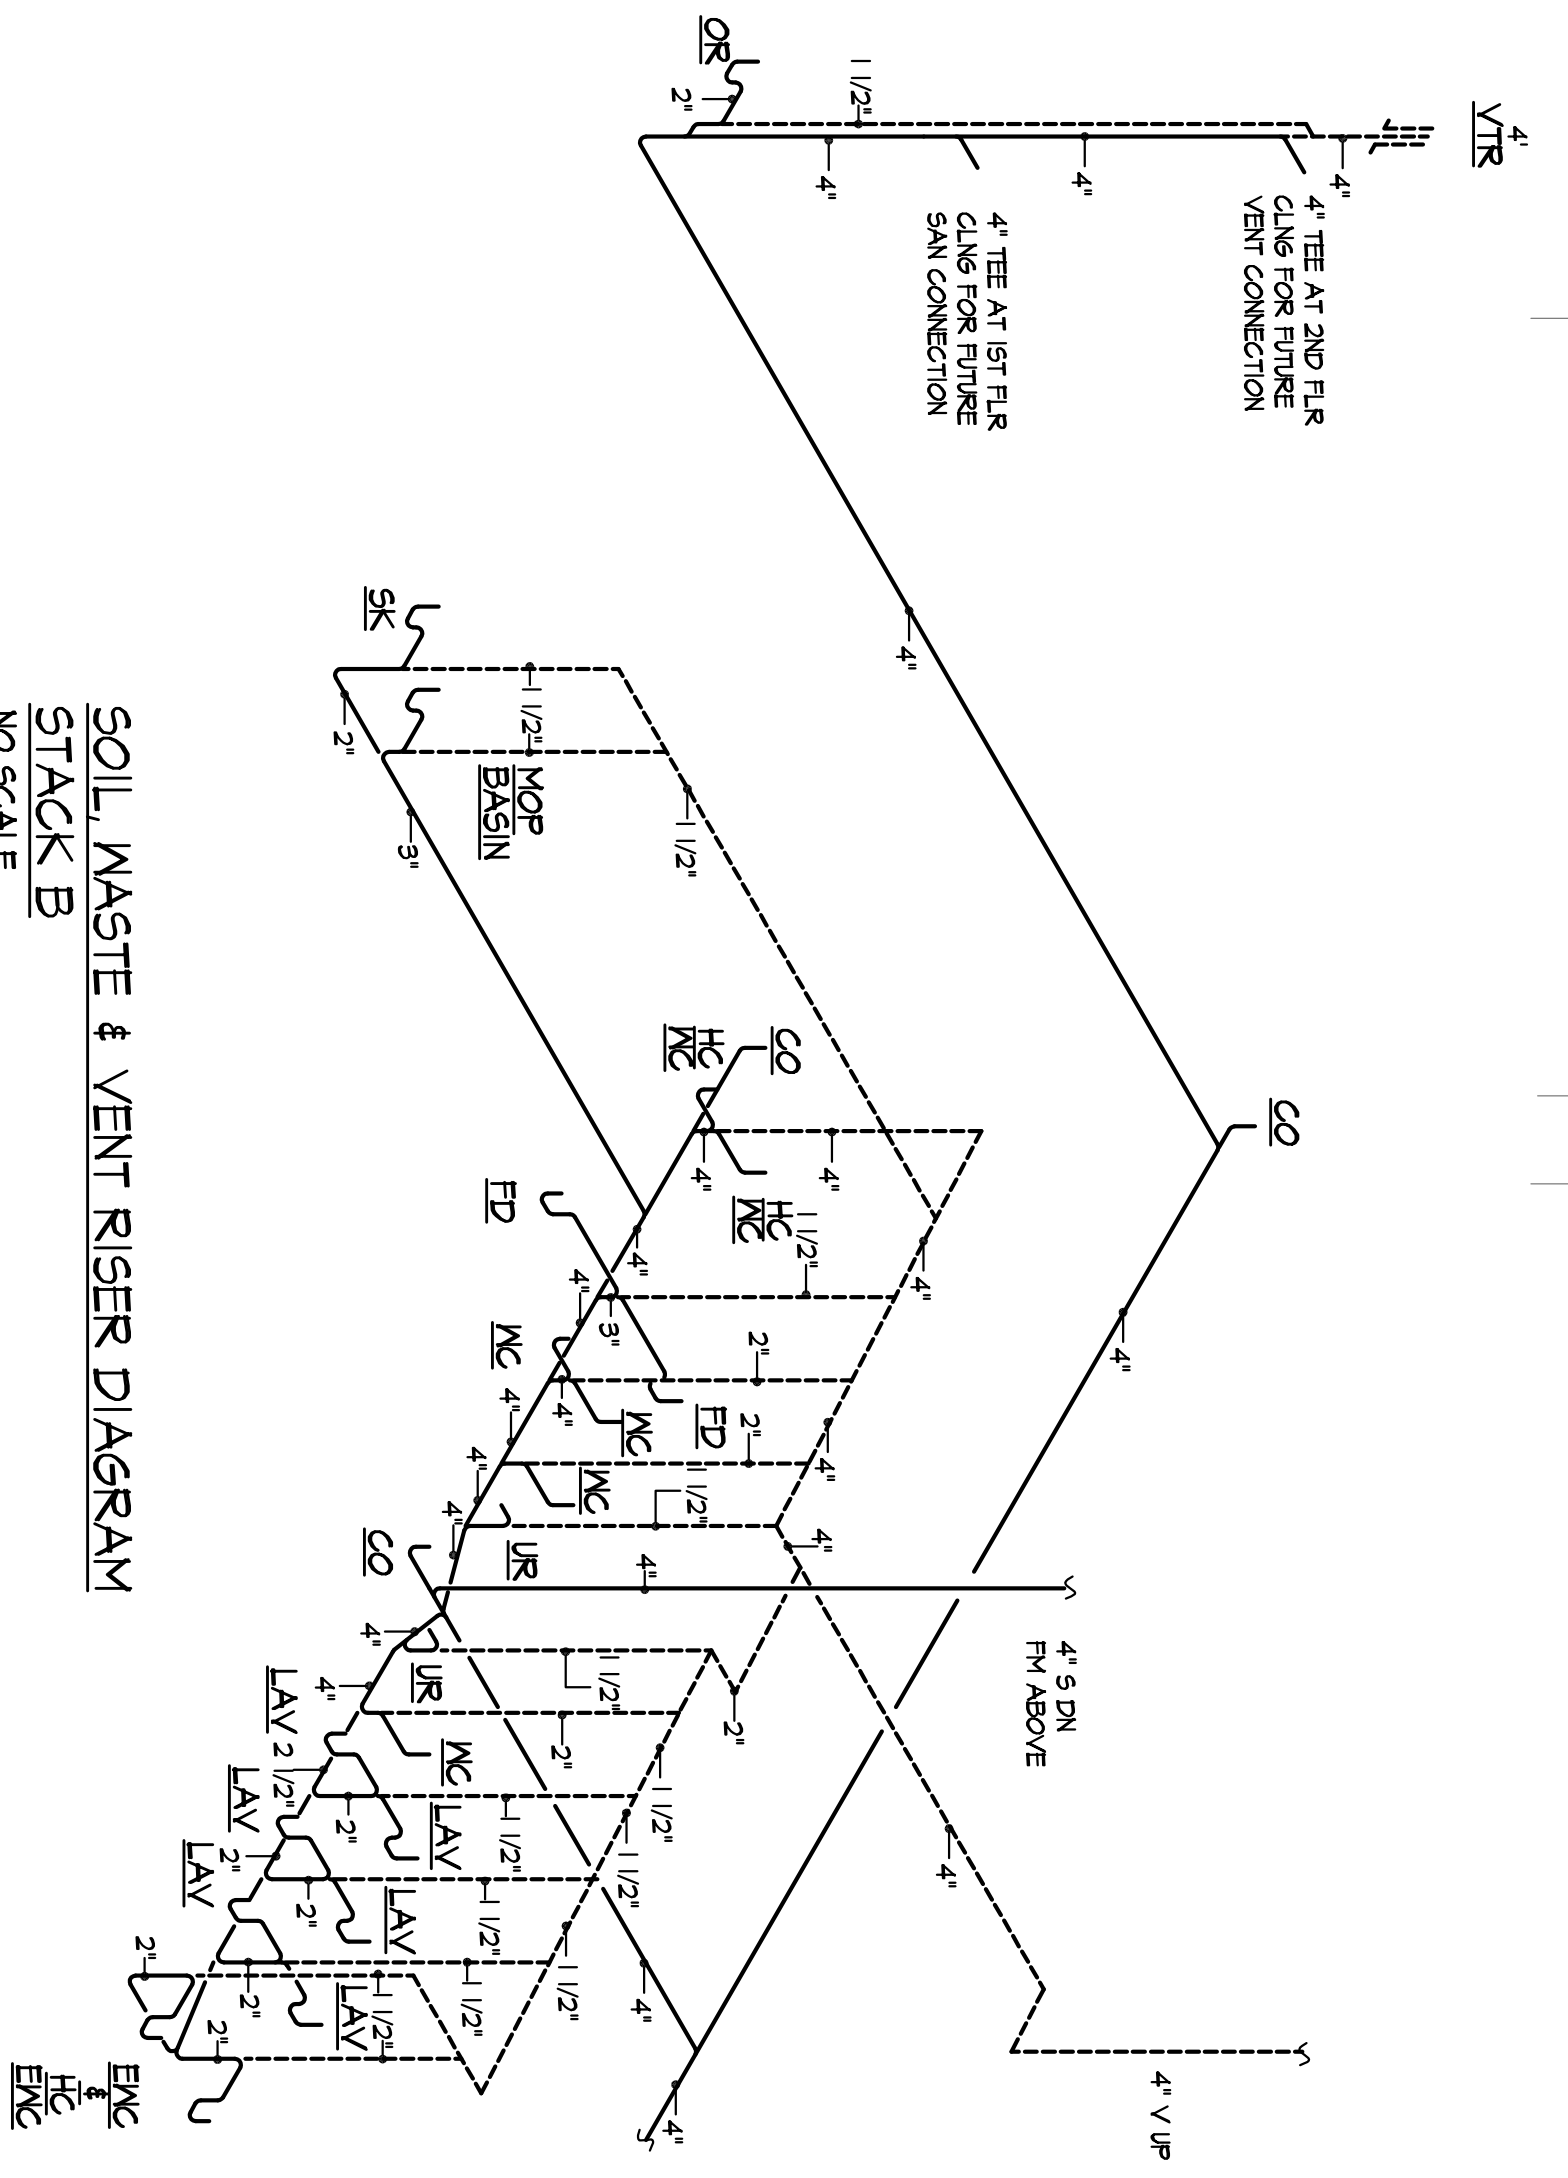

SOIL, WASTE & VENT RISER DIAGRAM
STACK B
NO SCALE

AVG: '04-Add
2nd Floor
Fit-Up.